


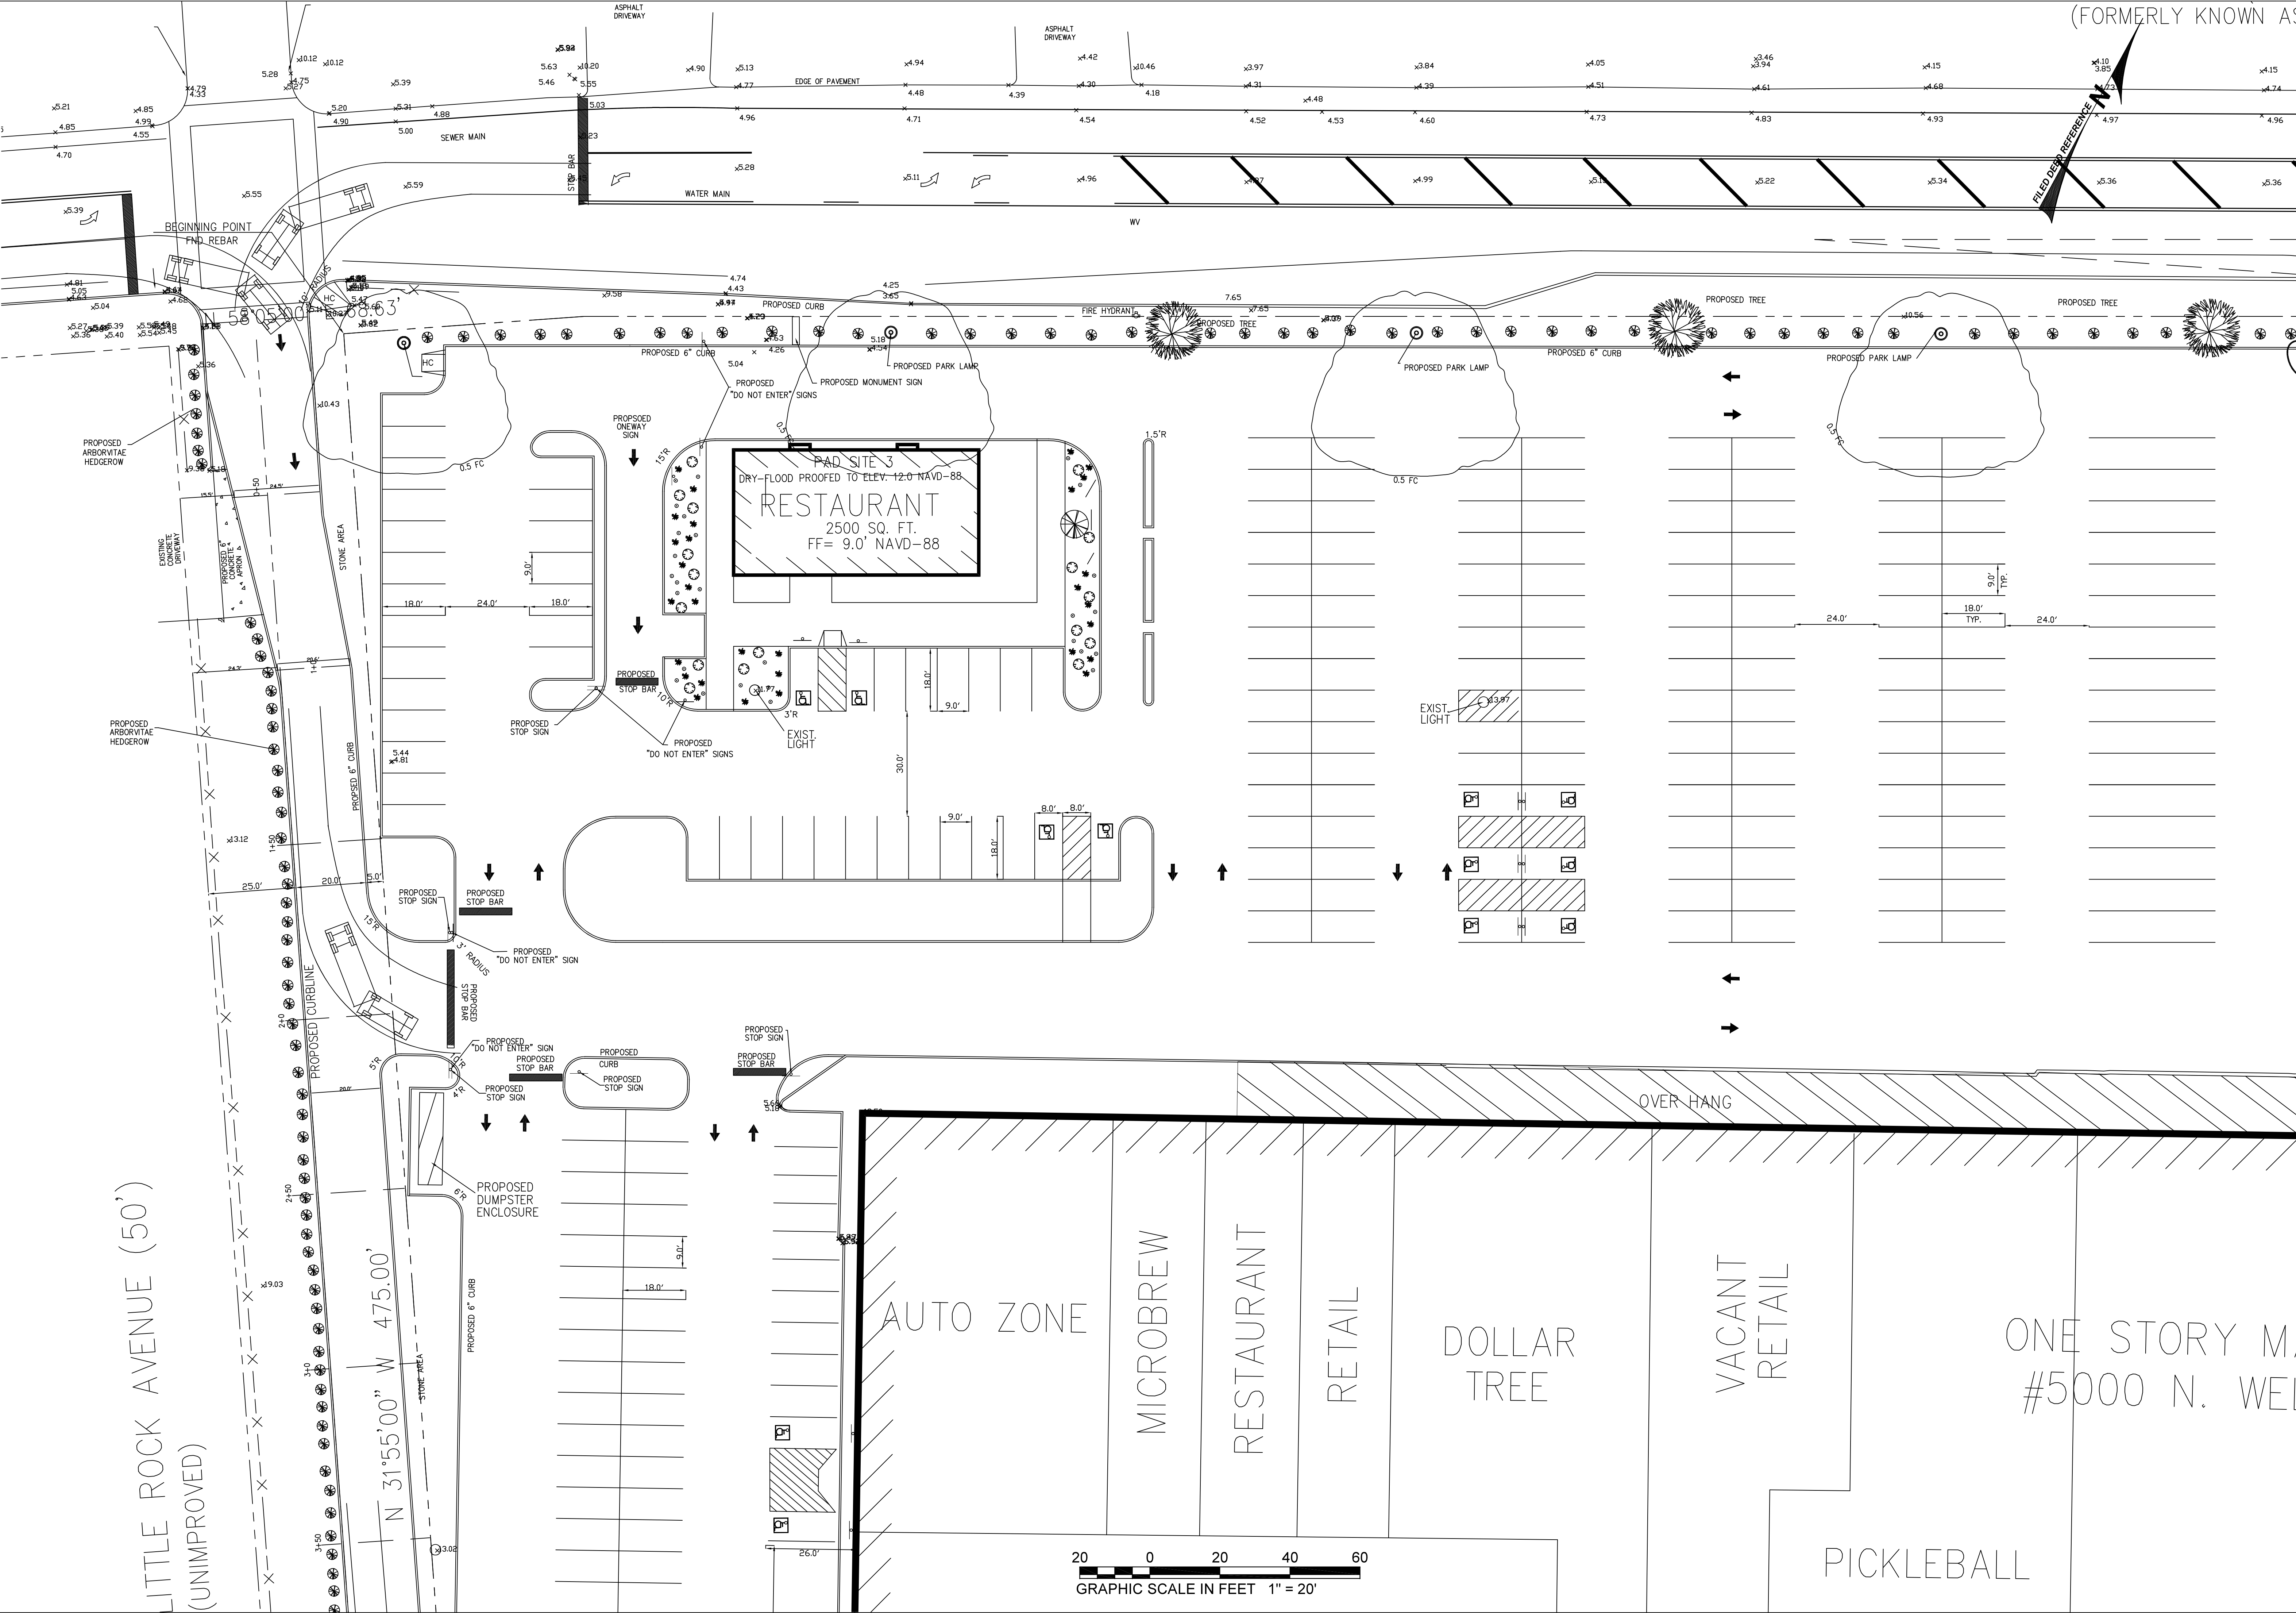

Matthew F. Doran
Matthew F. Doran Jr.
N.J. P.E. LIC. No. GE55764

Daniel J. Ponzo Sr.
Daniel J. Ponzo Sr.
N.J.P.L.S. LIC. No. 24CS03760300

DORAN
ENGINEERING, P.A.
ENGINEERS - SURVEYORS - PLANNERS
840 NORTH MAIN STREET
PLICKSANTVILLE, N.J. 08232
Telephone (609) 646-3111 Fax (609) 641-0592

SITE PLAN PAD SITE #3 S-5
VENTNOR PLAZA SHOPPING CENTER
5000 N. WELLINGTON AVENUE
BLOCK 304 LOT 1
CITY OF VENTNOR
ATLANTIC COUNTY, NEW JERSEY

REVISIONS		DATE		DESCRIPTION	
		DATE	BY	GENERAL	DESCRIPTION
1/25/23	MD JR.	1/25/23	MD JR.	GENERAL	DESCRIPTION
DWN: DJP SR, CKD: MD JR.					
SCALE: 1"=20'					
DATE: 8/2/2022					
PROJECT: 0001					
SHEET: 5 OF 22					